




**JIM WILSON
& ASSOCIATES**

FLOOR PLAN LEGEND

- 3 1/2" METAL STUDS WITH GYPSUM BOARD
(SEE FIRE PROTECTION PLAN FOR RATINGS)
- 6" METAL STUDS WITH GYPSUM BOARD
(SEE FIRE PROTECTION PLAN FOR RATINGS)
- 8" CONCRETE MASONRY UNIT - CMU
(SEE FIRE PROTECTION PLAN FOR RATINGS)
- STACKED STONE VENEER
- PRECAST CONCRETE
- CONCRETE STRUCTURAL COLUMN
(SEE STRUCTURAL PLANS)
- EOS
FOC
FOS
- EDGE OF SLAB
FACE OF CMU
FACE OF STUD

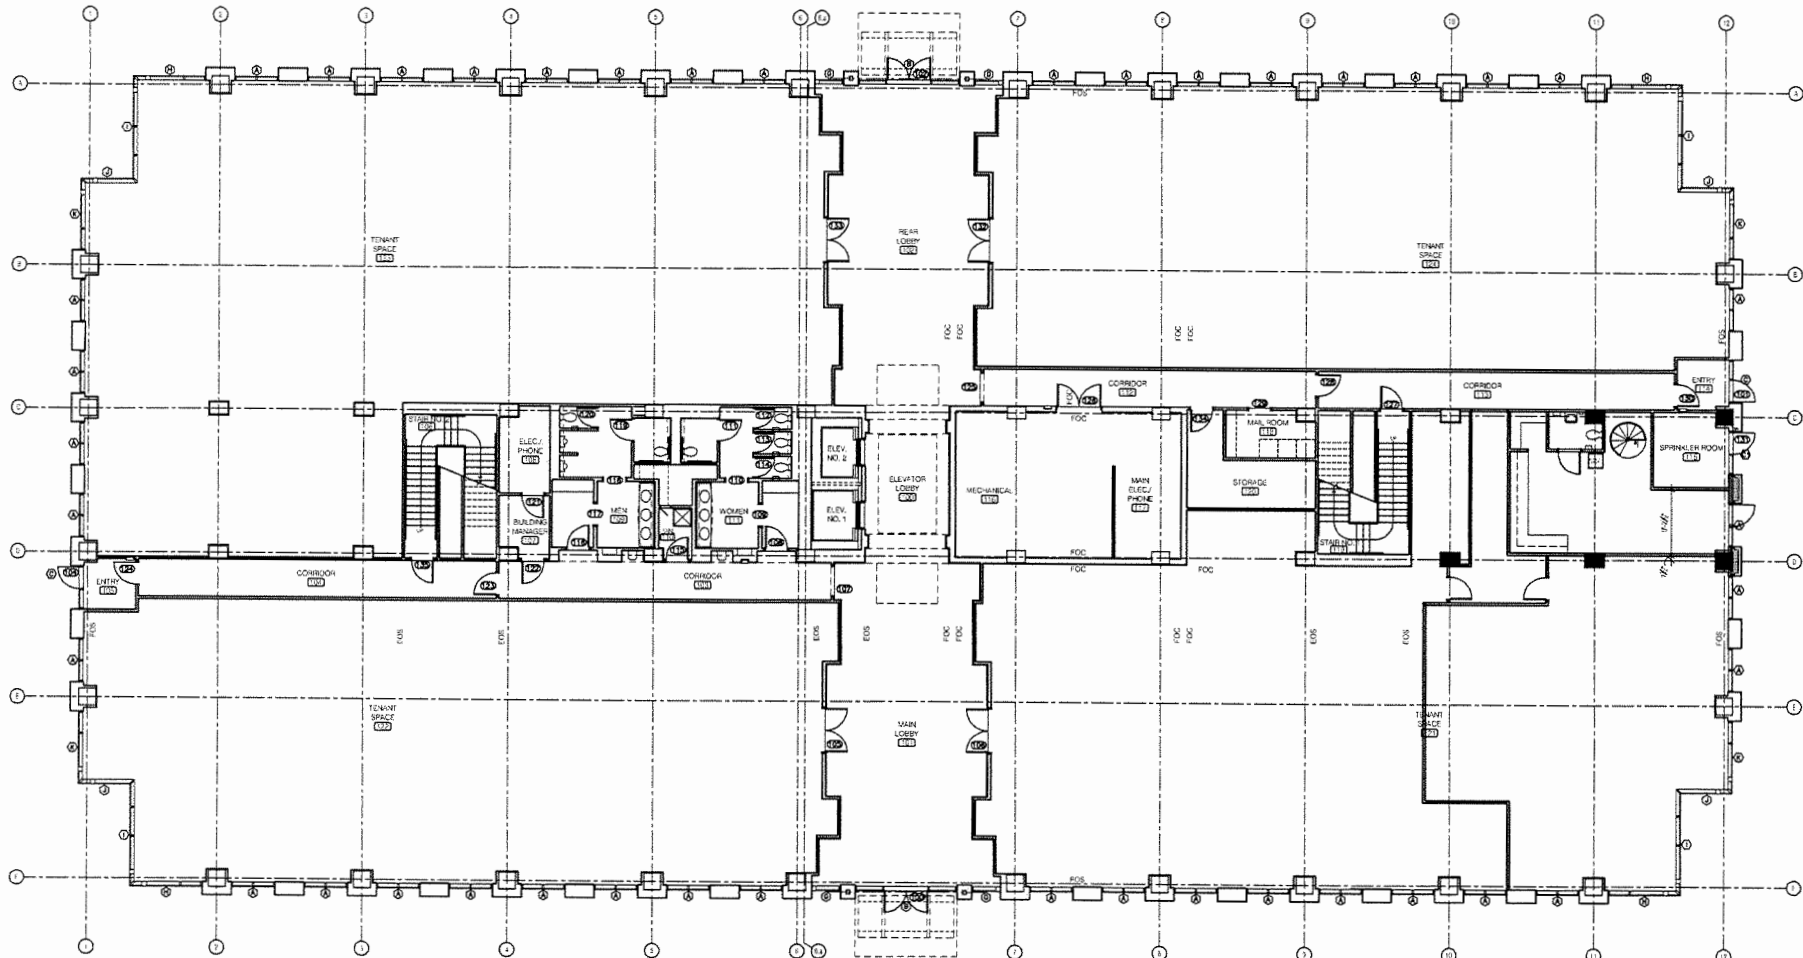

FIRST FLOOR PLAN
SCALE: 1/8" = 1'-0"

**GOODWYN, MILLS
& CAWOOD, INC.**
ENGINEERING
ARCHITECTURE
LANDSCAPE ARCHITECTURE
PLANNING

102 Franklin Park Drive, P.O. Box 100
Montgomery, Alabama 36103
Phone: (205) 271-0000
Fax: (205) 271-0000

1101 South 10th Street
Birmingham, Alabama 35203
Phone: (205) 944-0000
Fax: (205) 944-0000

1101 South 10th Street
Birmingham, Alabama 35203
Phone: (205) 944-0000
Fax: (205) 944-0000

STRUCTURAL ENGINEER
S.E.
The John Jones Group
Birmingham, Alabama 35202
Phone: (205) 944-0000
Fax: (205) 944-0000

MECHANICAL ENGINEER
S.E.
The John Jones Group
Birmingham, Alabama 35202
Phone: (205) 944-0000
Fax: (205) 944-0000

ELECTRICAL ENGINEER
S.E.
The John Jones Group
Birmingham, Alabama 35202
Phone: (205) 944-0000
Fax: (205) 944-0000

ELECTRICAL ENGINEER
S.E.
The John Jones Group
Birmingham, Alabama 35202
Phone: (205) 944-0000
Fax: (205) 944-0000

**EASTCHASE
OFFICE
BUILDING**
MONTGOMERY, ALABAMA

GM&C NO. 6-3-0

issue date	
PRELIMINARY	10/05/00
Design Development	11/05/00
FINAL	12/18/00

drawn by:
**FIRST FLOOR
PLAN**

A1.01